


DO NOT SCALE

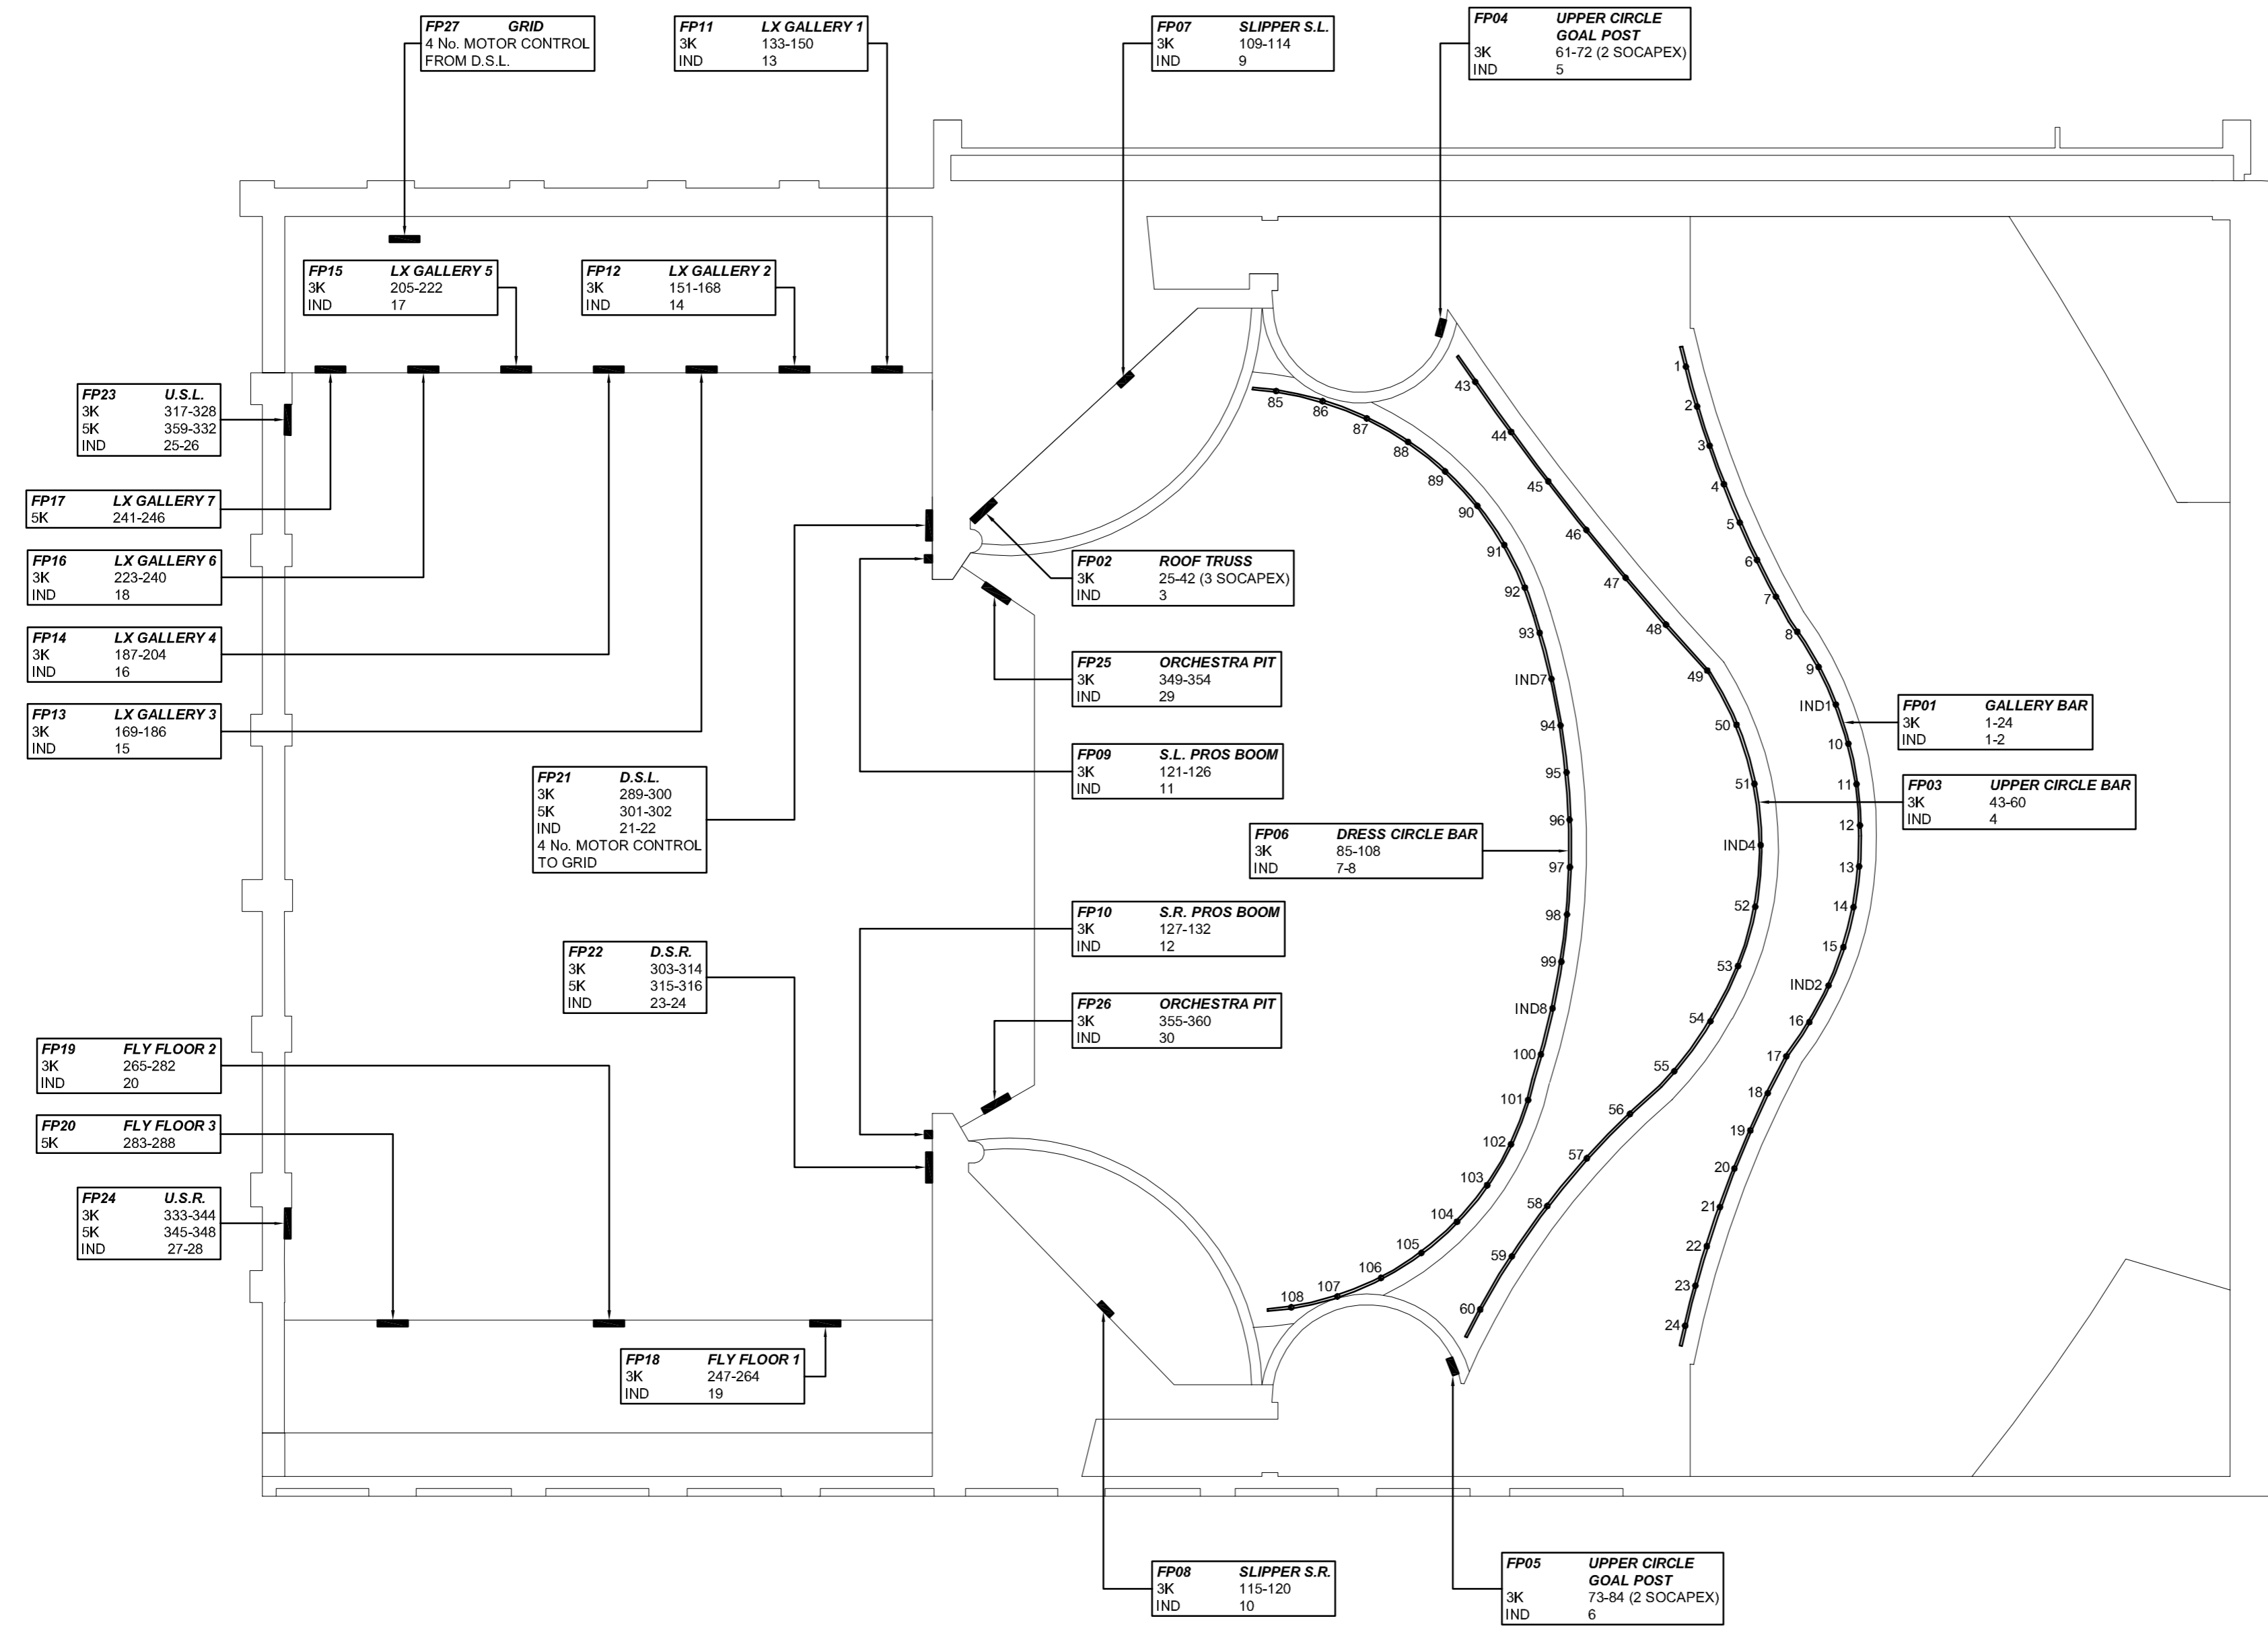

Notes:  
-

Issue	Date	Revision Notes	By
Drawing Status			

AS FITTED

Client  
CITY OF SUNDERLAND

Project  
PRODUCTION LIGHTING

Venue  
THE EMPIRE THEATRE, SUNDERLAND

Drawing Title  
PRODUCTION LIGHTING LAYOUT

Layout Name  
-

Drawing Number **7854-1900** Revision **-**

Drawn **A. PHILLIPS** Designed **T. FAGAN**

Design Dept Check Scale **1:100 @ A2**

Date **25.11.04**

Project Manager Approval

**FAGAN ELECTRICAL LIMITED**  
HIGHFIELD, SCHOOL LANE, KNOWSLEY VILLAGE, PRESCOT, MERSEYSIDE, L34 9ER  
TEL: 0151 948 8816, FAX: 0151 946 2516